


PARTITION LEGEND	
3 1/2" STUD WALL	
5 1/2" PLUMBING WALL	
1-HR RATED CMU WALL	
EXTERIOR CMU WALL	
1 HR RATED INTERIOR 6" STUD WALL	

AREA SCHEDULE	
UNIT	SF
1	1191
2	1191
3	1231
4	1173
5	1346
6	1173
7	1231
8	1231
9	1173
10	1346
11	1173
12	1231
13	1191
14	1191
TOTAL AREA:	17,072

14-PLEX PLUMBING FIXTURE SCHEDULE							
UNIT	SINKS	DISHWASHER	SHOWERS	LAVATORIES	WATER CLOSETS	WASHING MACHINE	TOTAL FIXTURES PER UNIT
1	1	1	2	4	3	1	12
2	1	1	2	5	3	1	13
3	1	1	2	5	3	1	13
4	1	1	2	4	3	1	12
5	1	1	2	5	3	1	13
6	1	1	2	4	3	1	12
7	1	1	2	5	3	1	13
8	1	1	2	5	3	1	13
9	1	1	2	4	3	1	12
10	1	1	2	5	3	1	13
11	1	1	2	4	3	1	12
12	1	1	2	5	3	1	13
13	1	1	2	5	3	1	13
14	1	1	2	4	3	1	12
TOTAL FIXTURES PER BUILDING	14	14	28	64	42	14	176

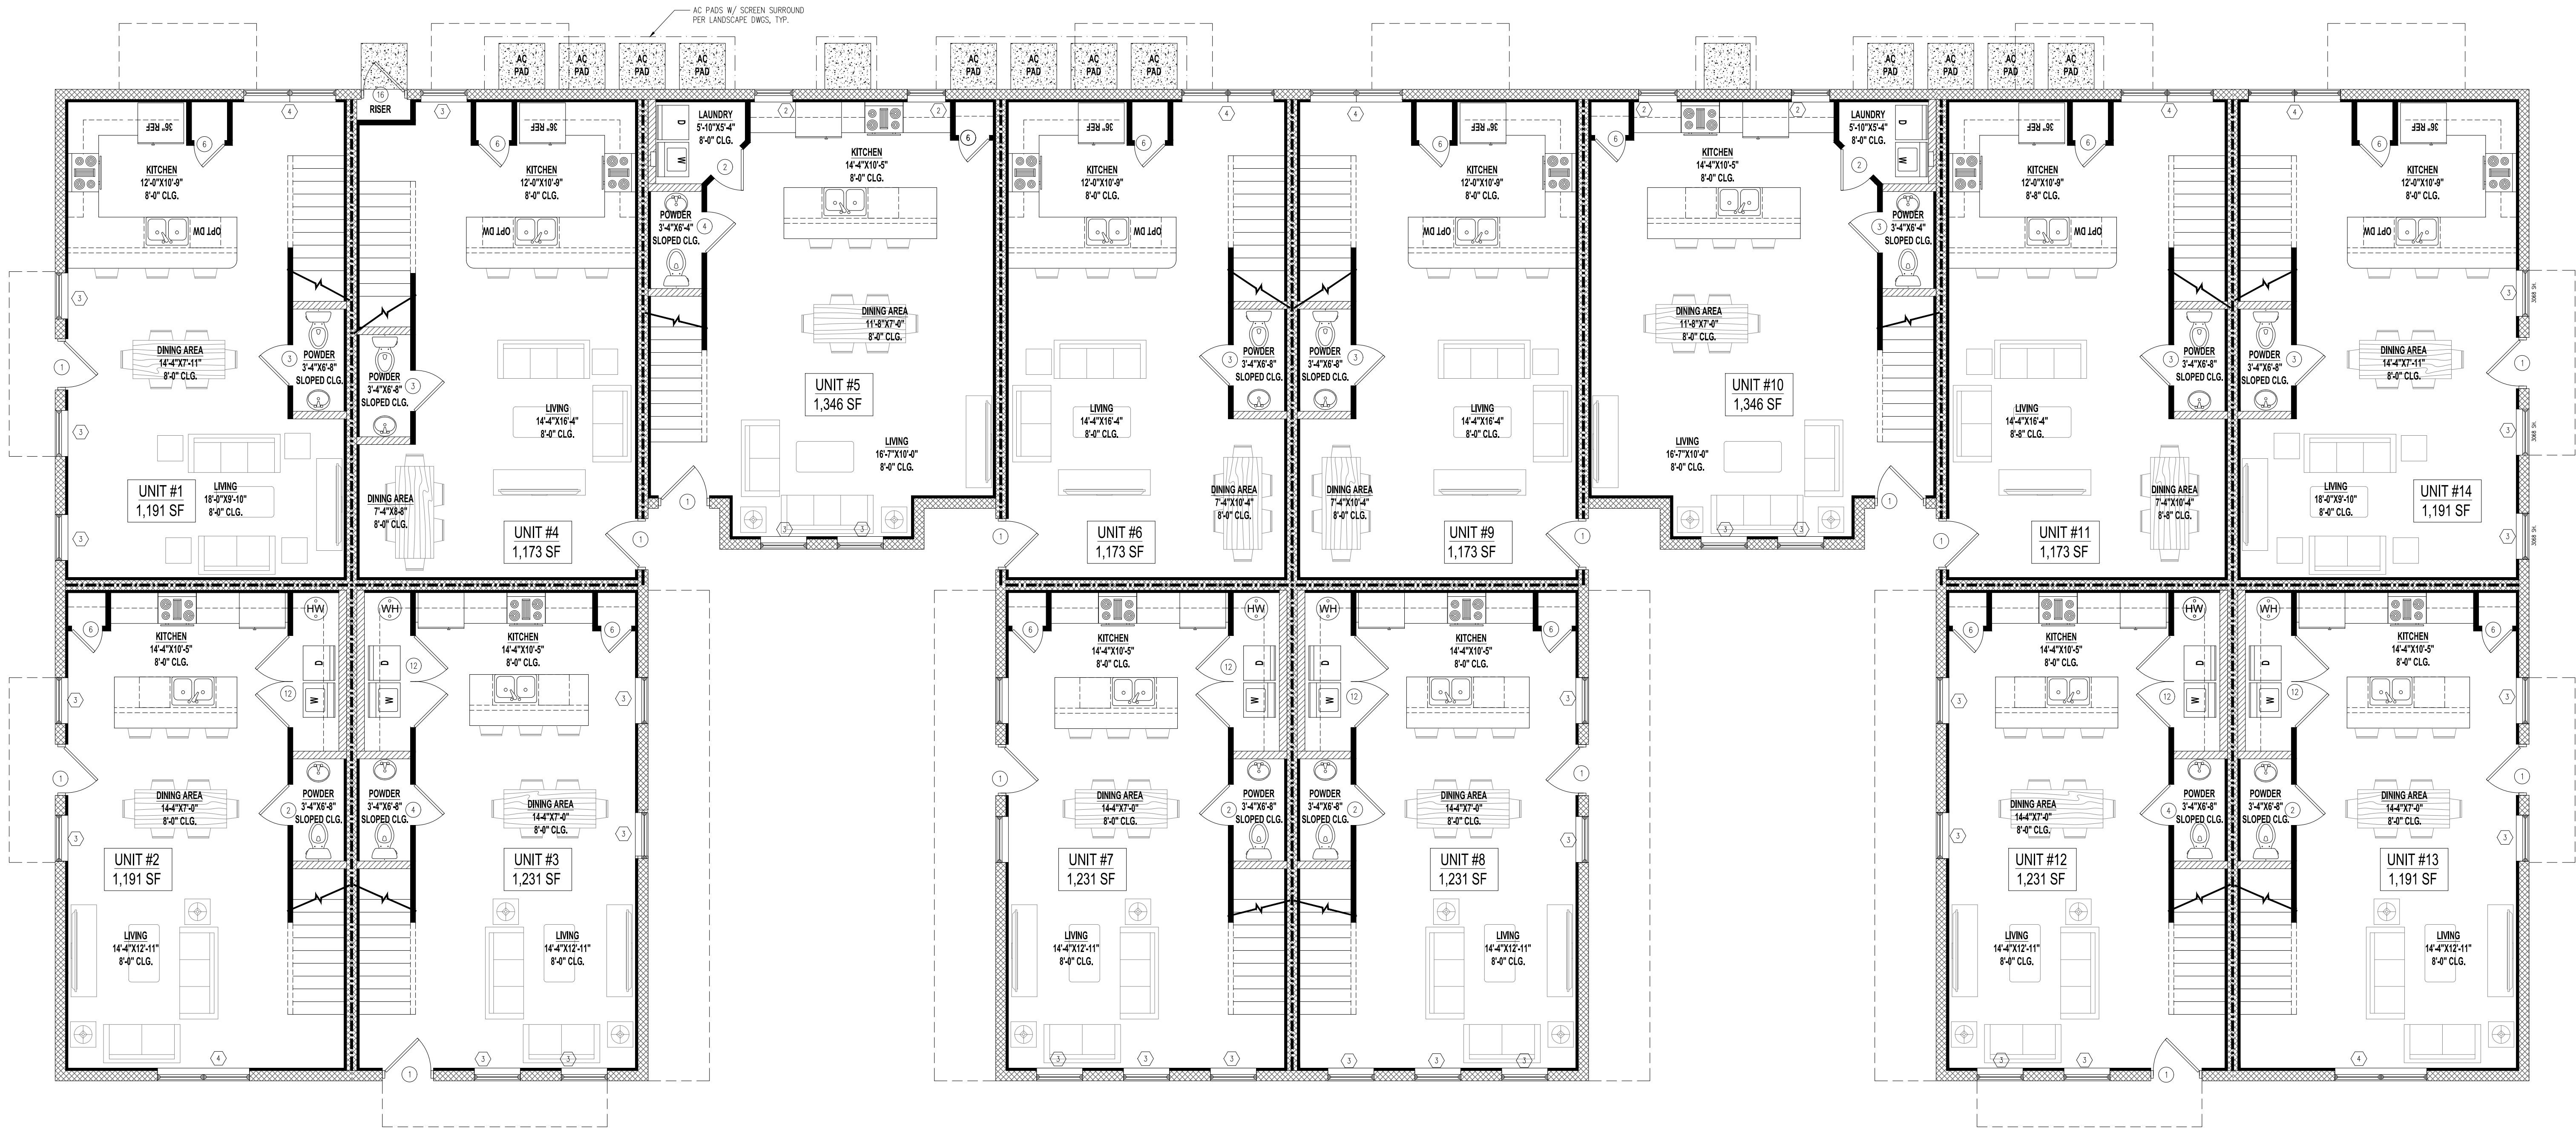

1 1ST FLOOR PLAN: 14-PLEX
A1.1 SCALE: 3/16" = 1'-0"

"NEW CONSTRUCTION - 14 PLEX"
FOR
SOUTHERN IMPRESSION HOMES


04.15.2022

20-030.04

A1.1

PERMIT SET

PARTITION LEGEND	
3 ½" STUD WALL	
5 ½" PLUMBING WALL	
1-HR RATED CMU WALL	
EXTERIOR CMU WALL	
1 HR RATED INTERIOR 6" STUD WALL	

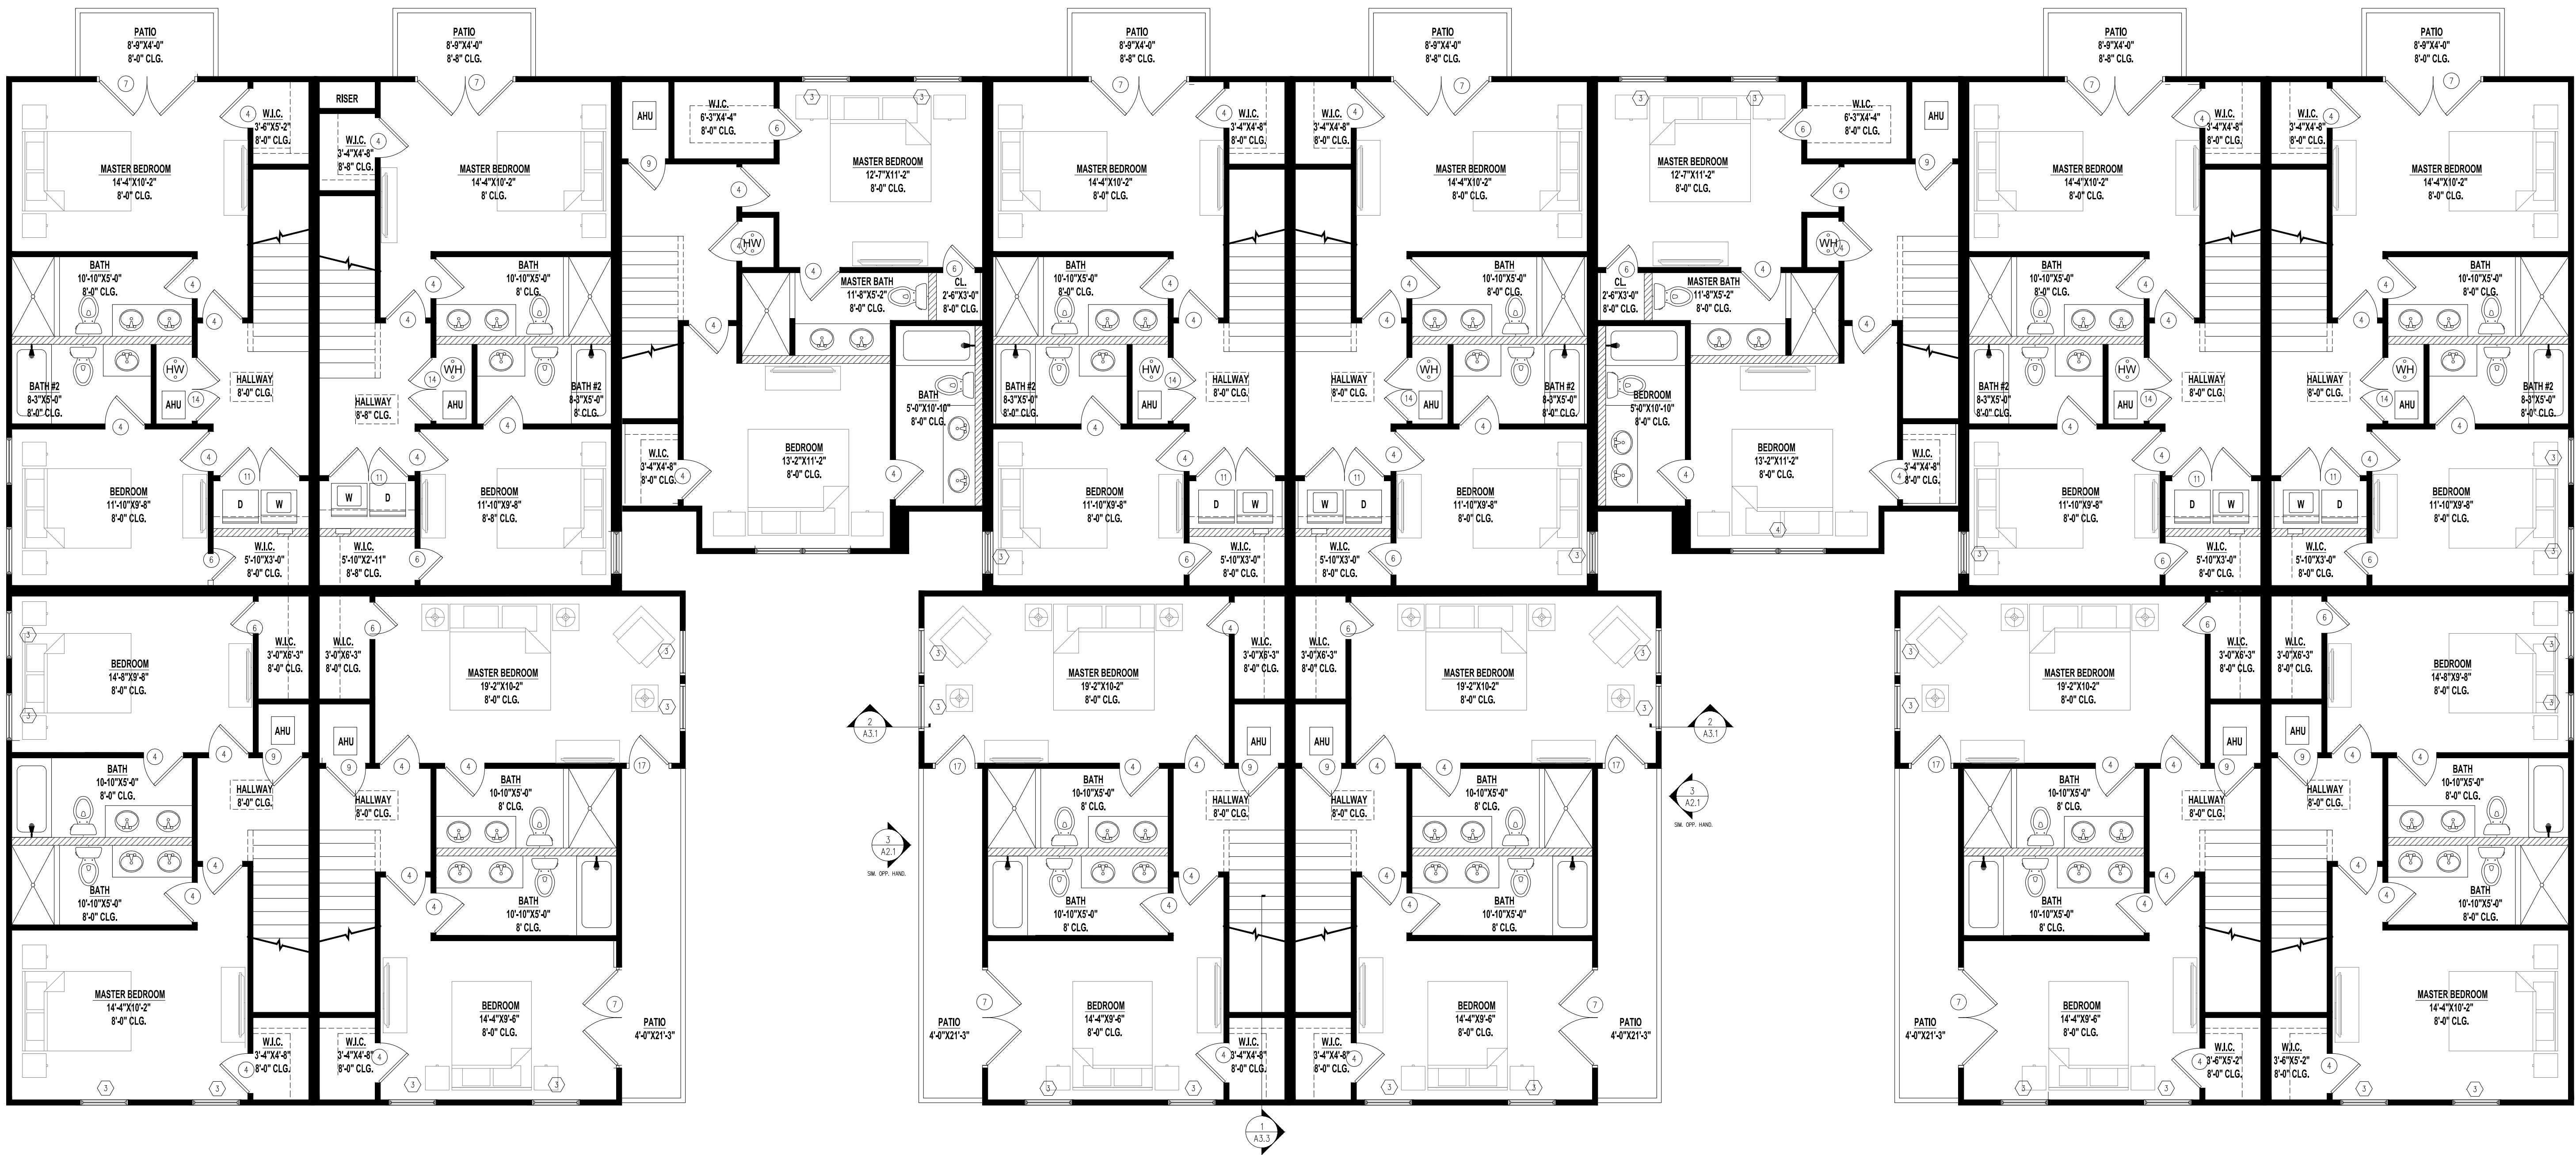

1 2ND FLOOR PLAN: 14-PLEX
A1.1 SCALE: 3/16" = 1'-0"

"NEW CONSTRUCTION - 14 PLEX"

FOR
SOUTHERN IMPRESSION HOMES

04.15.2022

20-030.04

A1.2

PERMIT SET